


THIS DRAWING IS THE EXCLUSIVE PROPERTY OF APPLIED COMPRESSION SYSTEMS AND SHALL NOT BE REPRODUCED WITHOUT WRITTEN PERMISSION FROM ACS

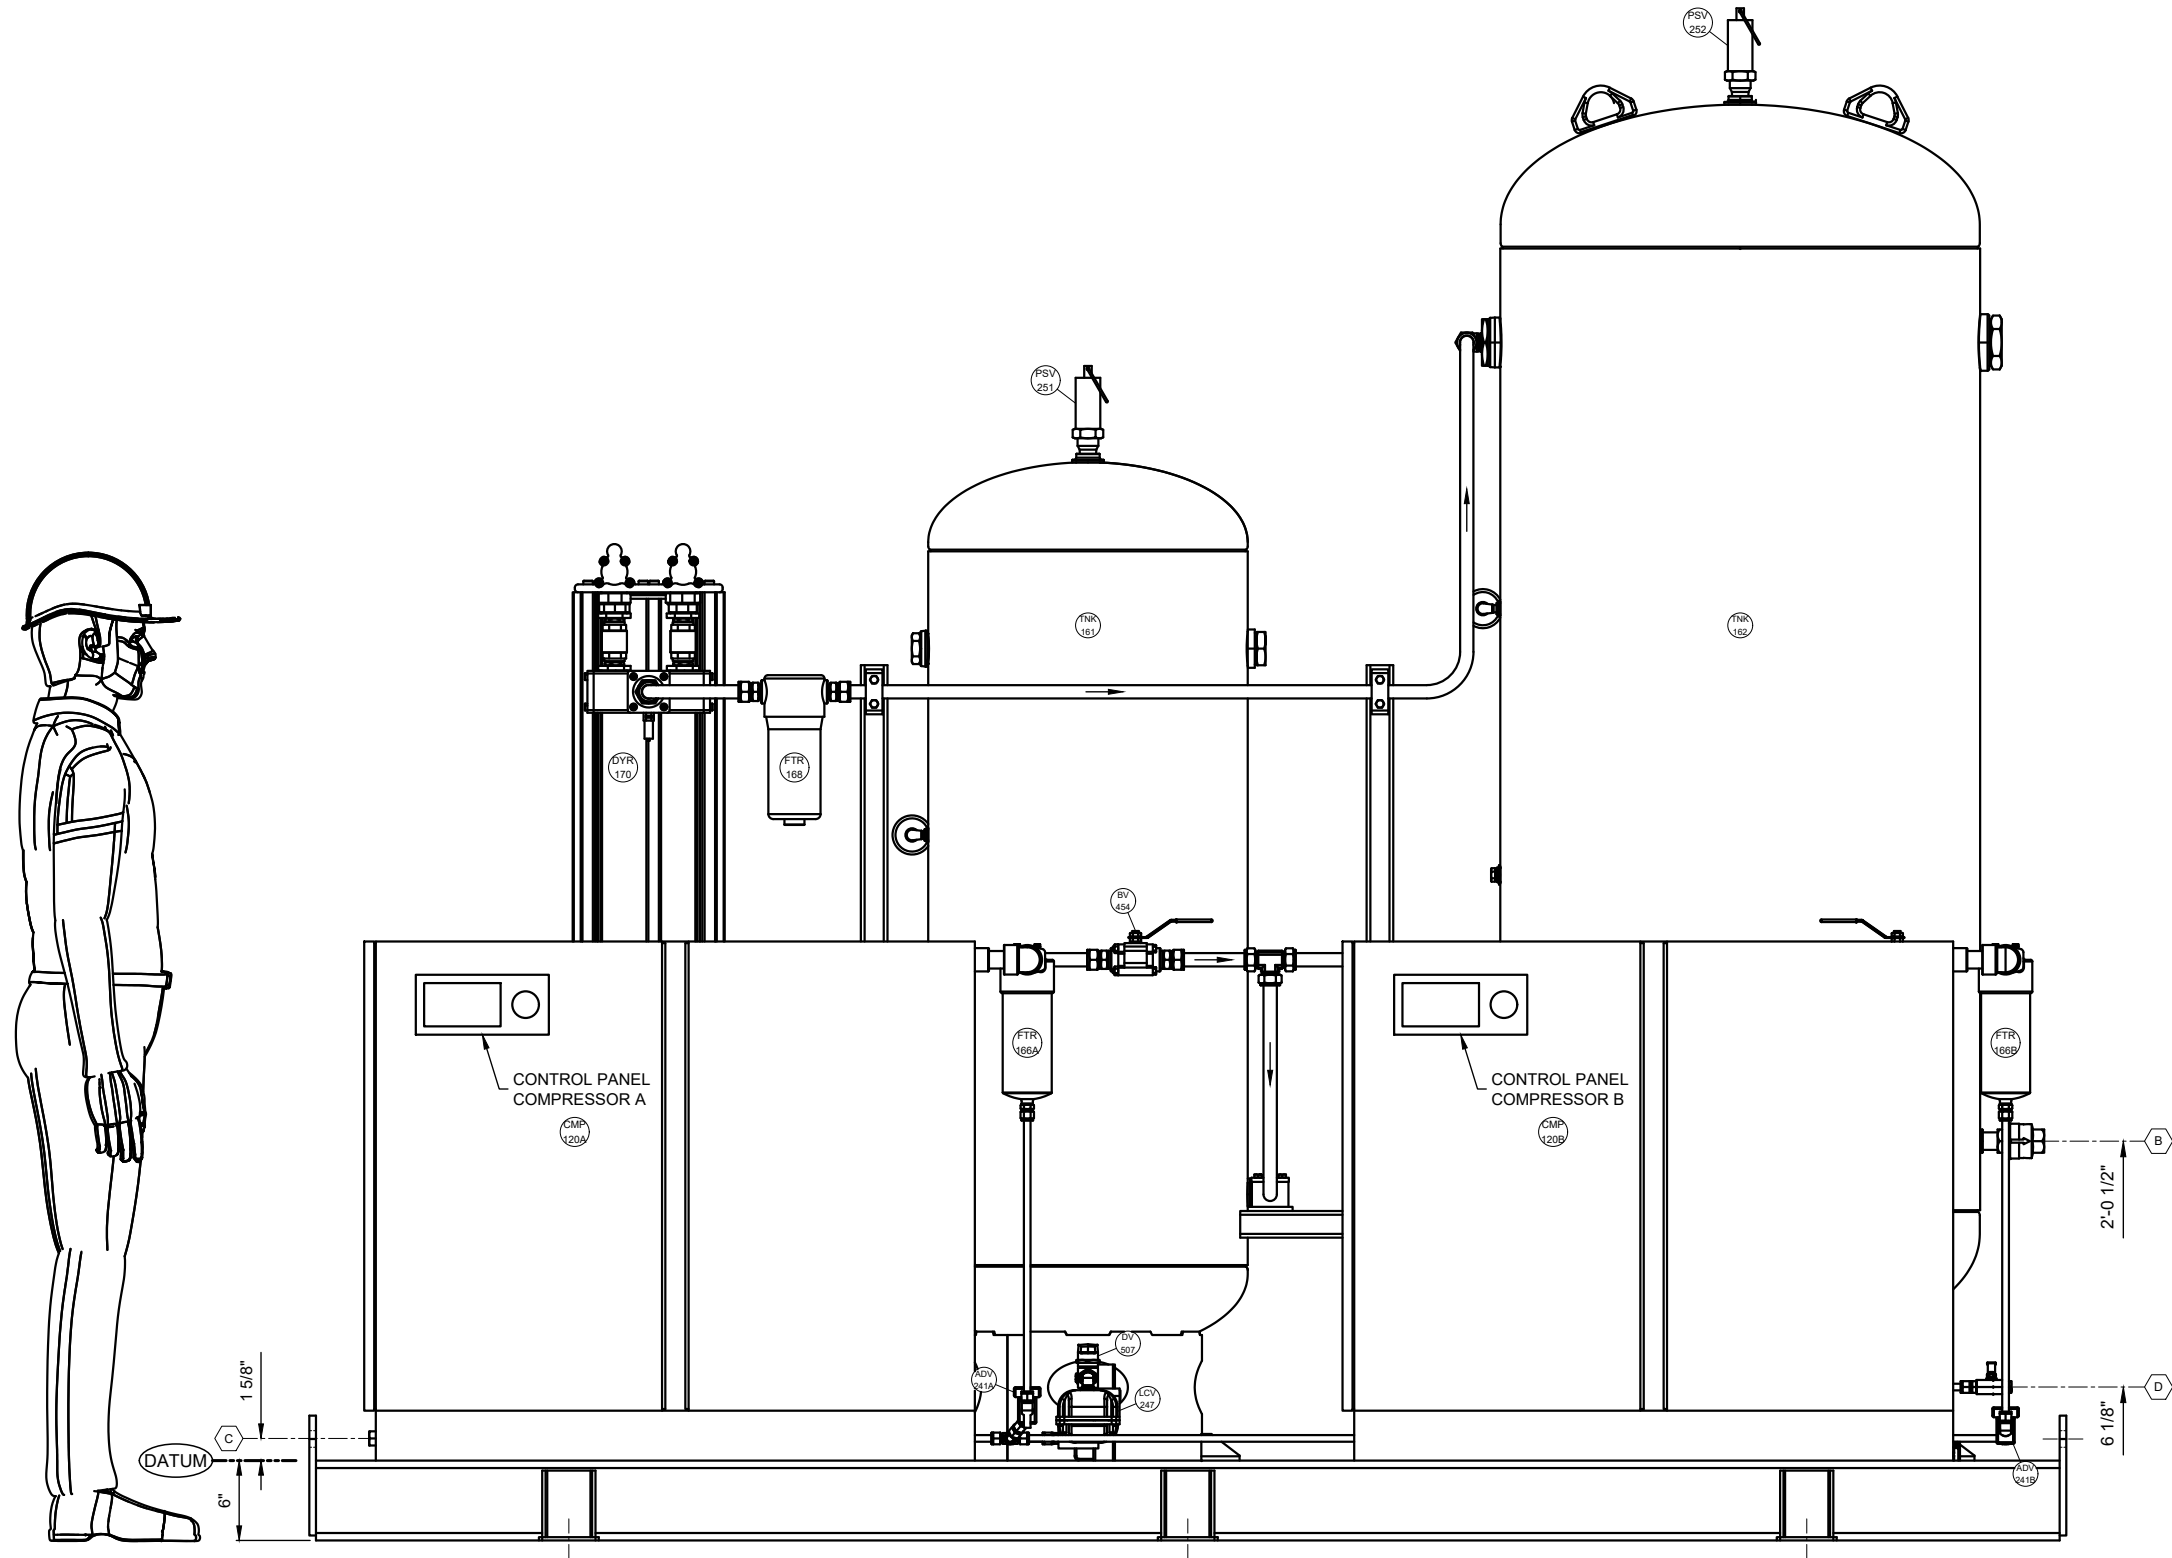

ELEVATION VIEW

AS-BUILT

SCHEDULE OF OPENINGS		
CONV	SIZE / RATING	SERVICE / DESCRIPTION
A	14" x 14" INLET FILTER	SUCTION INLET (ONE on EACH MACHINE)
B	1" - FNPT	PACKAGE DISCHARGE OUTLET
C	1/2" - FNPT	LIQUIDS DRAIN OUTLET
D	1/2" - FNPT	DRY TANK LIQUIDS DRAIN OUTLET
E		
F		
G		

GENERAL NOTES

- FABRICATION TOLERANCES = $\pm 3/8"$
- SEE GENERAL PROJECT NOTES ON PID-10272
- SEE PLAN VIEW GA-10272F-A, ELEV VIEW GA-10272F-C, and ISO Ref. VIEW GA-10272F-D
- PIPING LAYOUT, CONFIGURATION, AND ROUTING MAY VARY FROM WHAT IS SHOWN (EXCEPT CUSTOMER TERMINATION TIE-IN POINTS).

PACKAGE OVERALL DIMENSIONS
TOTAL PACKAGE DRY WEIGHT = Appx. 5000 LBS.
TOTAL PACKAGE LENGTH = 11'- 0"
TOTAL PACKAGE WIDTH = 7'- 0"
TOTAL PACKAGE HEIGHT = 9'- 7"

 400 Industrial Road "A" Cranbrook, British Columbia. V1C 4Z3 Canada Ph: (250) 417 - 2396 Fx: (250) 417 - 3183 www.appliedcompression.com "A world of compressed air and gas solutions"						Customer: ENCORE COMBUSTION					
						Project: VECTOR 3100 (DUPLEX) INSTR AIR COMP. PACKAGE 15 HP ELEC DRIVE RVD11H ROTARY VANE					
						Description: GENERAL ASSEMBLY (COMPRESSOR SIDE) ELEVATION VIEW					
						Location: AUSTIN, Texas					
						Job #:	ACJ-10272F	Tag #:	-	Cust PO:	P10946
1	UPDATED per AS-BUILT	CD	TB	NC	JUN 22/22	Drawn By:	TB	Date:	MAR 16/22	Qty Rec'd:	ONE
0	UPDATED for SHOP RELEASE	TB	NC	MS	MAR 25/22	Chk By:	NC	Date:	MAR 17/22	Scale:	1 : 14 (at 11 x 17)
A	UPDATED for CUSTOMER ISSUE	TB	NC	MS	MAR 20/22	App By:	MS	Date:	MAR 18/22	Dwg #:	GA-10272F-B
Rev	Description	Dwn	Chk	App	Date						Rev: 1